


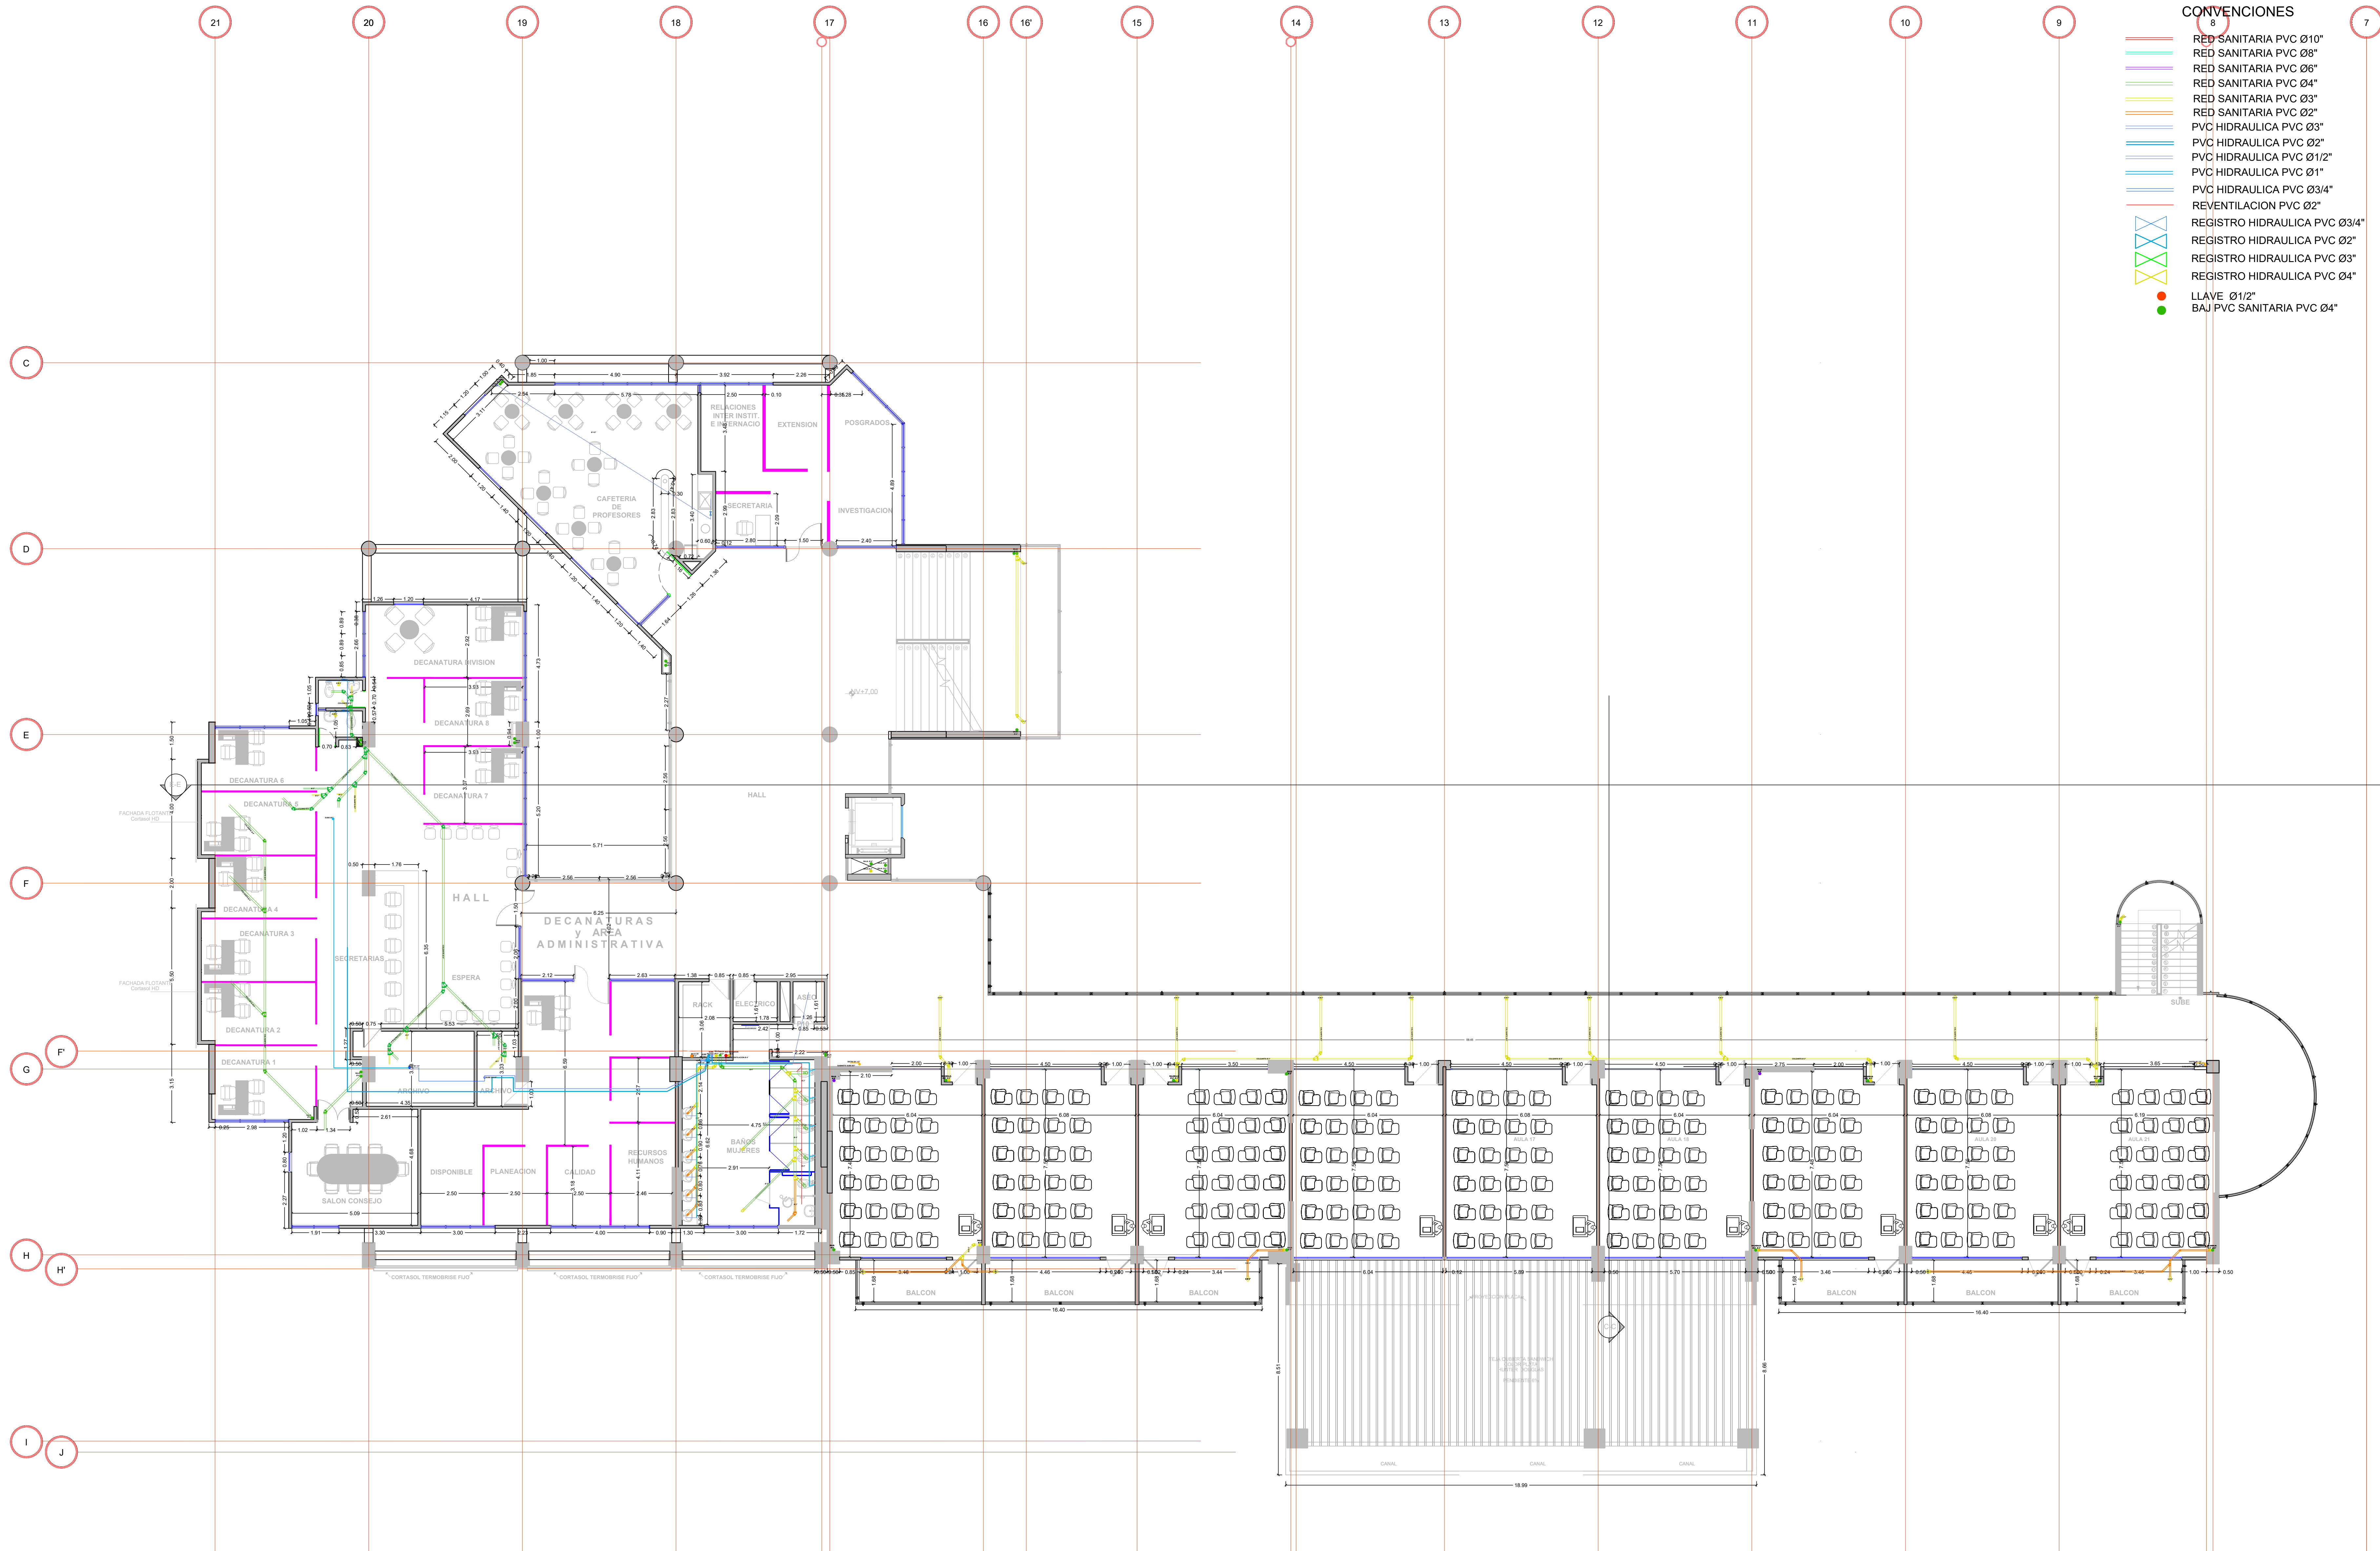

- CONVENCIONES
- RED SANITARIA PVC Ø10"
 - RED SANITARIA PVC Ø8"
 - RED SANITARIA PVC Ø6"
 - RED SANITARIA PVC Ø4"
 - RED SANITARIA PVC Ø3"
 - RED SANITARIA PVC Ø2"
 - PVC HIDRAULICA PVC Ø3"
 - PVC HIDRAULICA PVC Ø2"
 - PVC HIDRAULICA PVC Ø1/2"
 - PVC HIDRAULICA PVC Ø1"
 - PVC HIDRAULICA PVC Ø3/4"
 - REVENTILACION PVC Ø2"
 - REGISTRO HIDRAULICA PVC Ø3/4"
 - REGISTRO HIDRAULICA PVC Ø2"
 - REGISTRO HIDRAULICA PVC Ø3"
 - REGISTRO HIDRAULICA PVC Ø4"
 - LLAVE Ø1/2"
 - BAJ PVC SANITARIA PVC Ø4"

 UNIVERSIDAD SANTO TOMAS PRIMER CLAUSTRO UNIVERSITARIO DE COLOMBIA	PROYECTO : DISEÑO REDES HIDROSANITARIAS CAMPUS AGUAS CLARAS UNIVERSIDAD SANTO TOMAS SEDE VILLAVICENCIO	DISEÑO :  GONZALO HERNANDEZ PARDO. MP: 25260089936 CND	CONTENIDO : PLANTA GENERAL - RED HIDRO-SANITARIAS PISO 3	OBSERVACIONES : 	FECHA : 	VERSION : 1	ESCALA : 1/100	PLANO : 6 de 8
					DIGITALIZADO : J A L C	FECHA : MAYO DE 2013		