
 

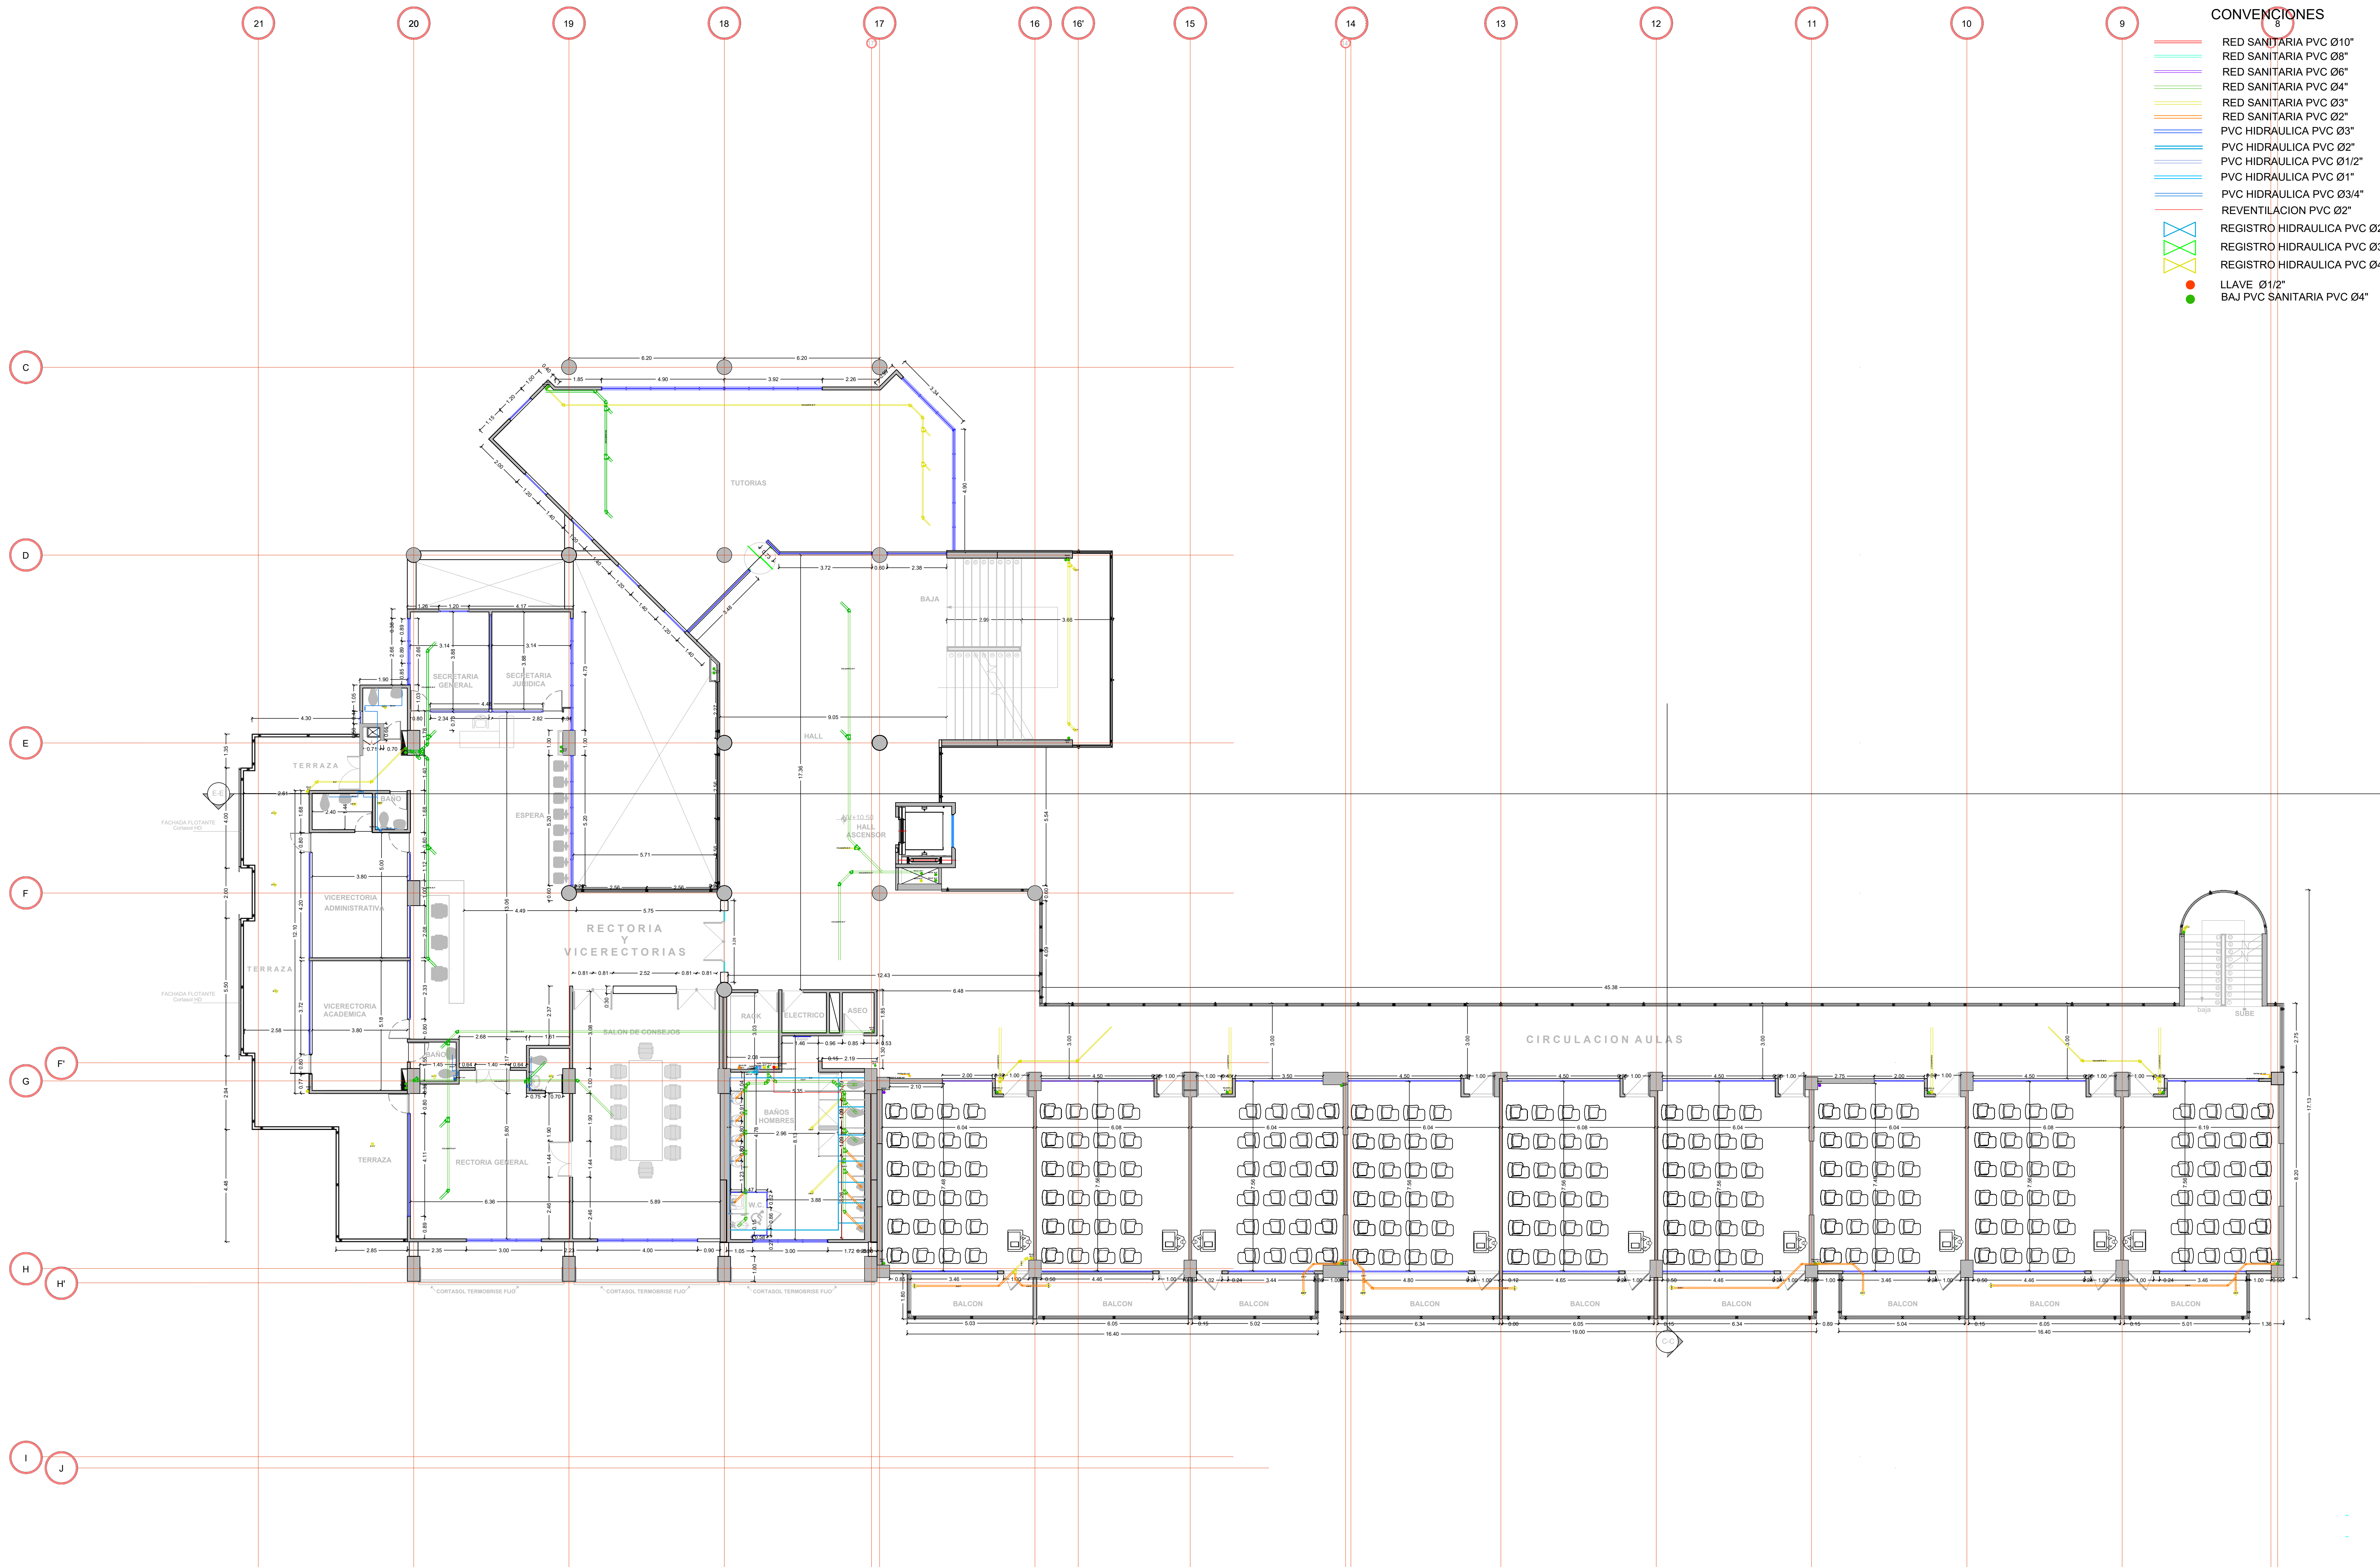


CONVENCIONES

- RED SANITARIA PVC Ø10"
- RED SANITARIA PVC Ø8"
- RED SANITARIA PVC Ø6"
- RED SANITARIA PVC Ø4"
- RED SANITARIA PVC Ø3"
- RED SANITARIA PVC Ø2"
- PVC HIDRAULICA PVC Ø3"
- PVC HIDRAULICA PVC Ø2"
- PVC HIDRAULICA PVC Ø1½"
- PVC HIDRAULICA PVC Ø1"
- PVC HIDRAULICA PVC Ø¾"
- REVENTILACION PVC Ø2"
-  REGISTRO HIDRAULICA PVC Ø2"
-  REGISTRO HIDRAULICA PVC Ø3"
-  REGISTRO HIDRAULICA PVC Ø4"
- LLAVE Ø1/2"
- BAJ PVC SANITARIA PVC Ø4"



PRODUCED BY AN AUTODESK STUDENT VERSION

PRODUCED BY AN AUTODESK STUDENT VERSION



PROYECTO :
**DISEÑO REDES HIDROSANITARIAS
 CAMPUS AGUAS CLARAS UNIVERSIDAD
 SANTO TOMAS SEDE VILLAVICENCIO**

DISEÑO : 
GONZALO HERNANDEZ PARDO.
 MP: 25260089936 CND

CONTENIDO :
**PLANTA GENERAL - RED HIDRO-SANITARIAS
 PISO 4**

OBSERVACIONES :	FECHA :

VERSION :
1
 DIGITALIZADO :
J A L C

ESCALA :
1/100
 FECHA :
MAYO DE 2013

PLANO :
7 de 8